
 








**ELECTRICAL LEGEND**


-  1'X4' FLUORESCENT LIGHT
-  DUPLEX RECEPTACLES 15 AMP
-  LIGHT SWITCH
-  5000BTU A/C UNIT
-  100 AMP 220 VOLT SINGLE PHASE PANEL



  
**FLOOR PLAN**

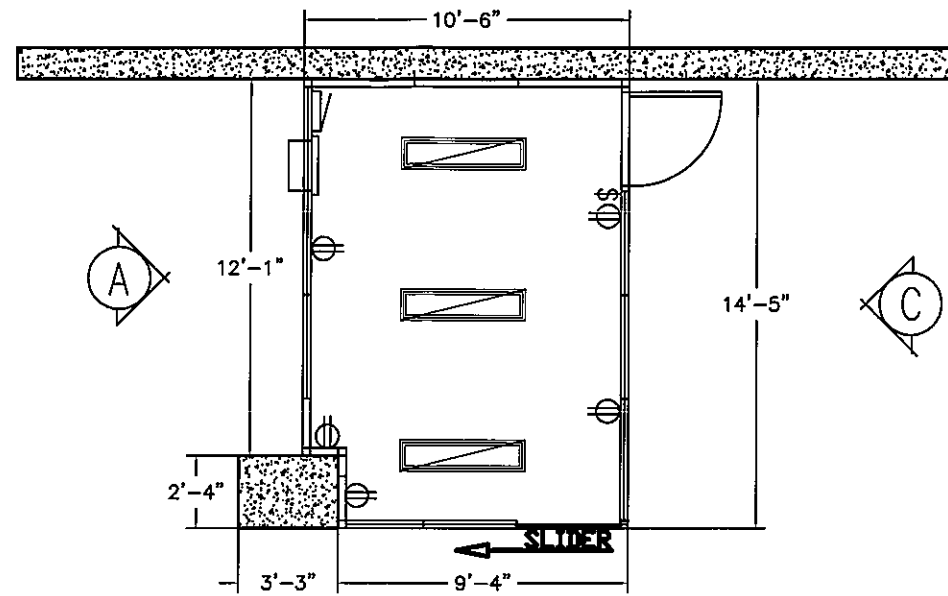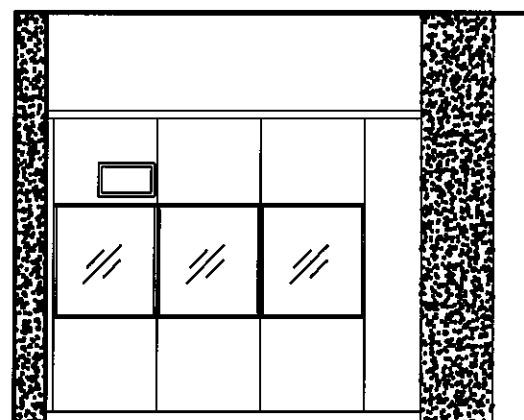

**ELEVATION A**

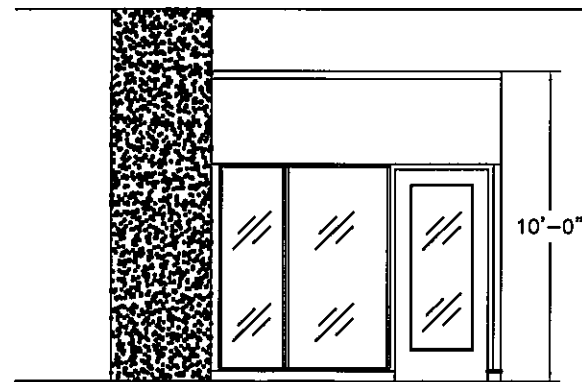

**ELEVATION B**

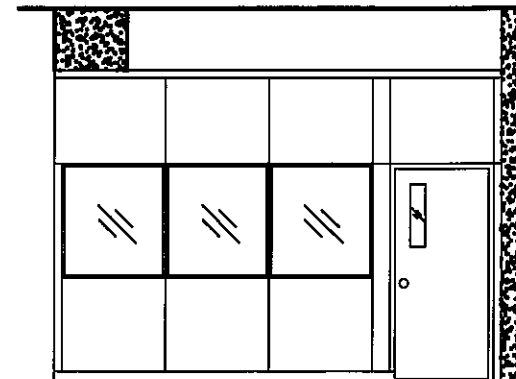

**ELEVATION C**

REVISIONS			
REV	DESCRIPTION	Date	APPROVED



CUSTOMER:			
ENTERPRISE HOLDINGS			
LOCATION: 181 BAY STREET			
TORONTO, ON.			
JOB NAME:			
PARKING KIOSK P3			
DWG/JOB NO: 15-000-06	BY: ASF		
QUOTE NO: AF15-510-06	YR	MO	DY
SHEET NO: 10F1	15	10	13
SCALE: NTS	REV.NO	0	



Provincial Partitions Ltd.